


COPYRIGHT AND OWNERSHIP OF THIS DRAWING IS VESTED IN DENNANY REIDY ASSOCIATES. NO PART OF THIS DOCUMENT MAY BE REPRODUCED OR TRANSMITTED IN ANY FORM OR STORED IN ANY RETRIEVAL SYSTEM OF ANY NATURE WITHOUT THE WRITTEN PERMISSION OF DENNANY REIDY ASSOCIATES AS COPYRIGHT HOLDER EXCEPT AS AGREED FOR USE ON THE PROJECT FOR WHICH THE DOCUMENT WAS ORIGINALLY ISSUED ©

ALL RIGHT RESERVED BY THE LAW OF COPYRIGHT AND BY INTERNATIONAL COPYRIGHT CONVENTIONS ARE RESERVED TO DENNANY REIDY ASSOCIATES. ©

**NOTES:**

1. USE FIGURED DIMENSIONS ONLY DO NOT SCALE.
2. DRAWINGS TO BE READ IN CONJUNCTION WITH ALL RELEVANT ENGINEER'S, ARCHITECT'S AND SERVICE ENGINEER'S DRAWINGS AND SPECIFICATIONS.

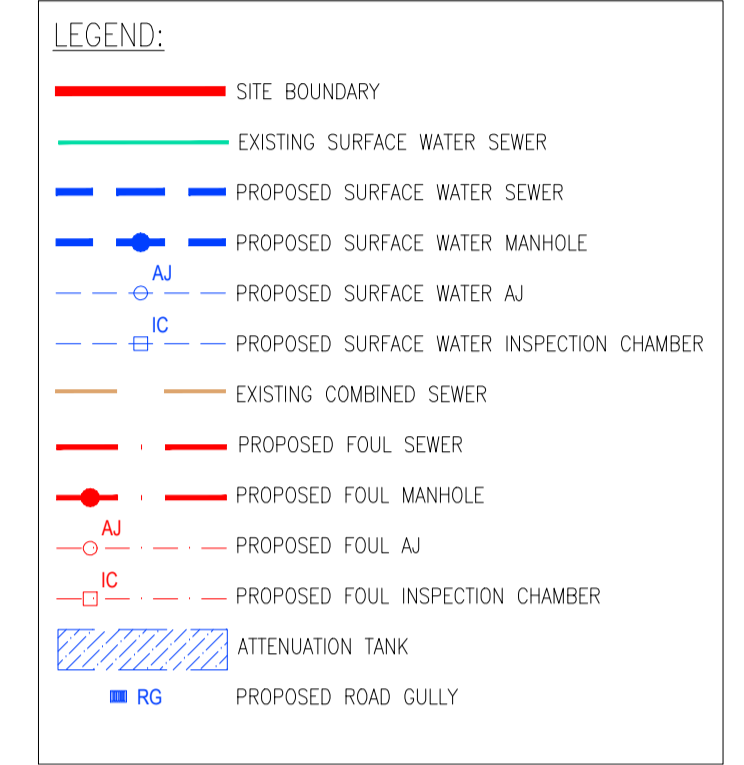

**IRISH WATER STANDARD DETAILS AND CODE PRACTICE:**

ALL OF THE SITE DRAINAGE WORKS SHOULD BE CARRIED OUT IN ACCORDANCE WITH IRISH WATER'S (IW) "WASTEWATER INFRASTRUCTURE STANDARD DETAILS" AND "CODE OF PRACTICE FOR WASTEWATER INFRASTRUCTURE".

FOR REINFORCED IN SITU ITEMS SUCH AS MANHOLES ETC. ALLOW H12 REBAR@200c/c BOTH FACES. NOTE THAT PRECAST OPTIONS ARE ALSO SPECIFIED.

**PIPE MATERIALS:**

1. SERVICE CONNECTIONS FROM DWELLING TO BE 100mm Ø UNPLASTICISED PVC IN ACCORDANCE WITH SECTION 3.13 OF IW CODE PRACTICE.
2. SITE SEWER TO BE THERMOPLASTIC STRUCTURED WALL PIPES IN ACCORDANCE WITH SECTION 3.13 OF THE IW CODE OF PRACTICE.

**TESTING:**

1. SITE SEWER AND MANHOLES TO BE TESTED IN ACCORDANCE WITH SECTION 4.10 OF IW CODE OF PRACTICE.
2. CCTV AND MANHOLE CONDITION SURVEYS TO BE CARRIED OUT IN ACCORDANCE WITH SECTION 1.9 OF IW CODE OF PRACTICE IN ADVANCE OF THE DEFECTS LIABILITY PERIOD.

NOTE: ALL MANHOLE COVER LEVELS TO BE CHECKED IN SITU TO ENSURE THAT THEY ARE LEVEL WITH THE SURROUNDING FINISHED SURFACES.

B	GENERAL REVISION	02.07.18	STR	RP
A	SITE PLAN UPDATED	10.05.18	STR	RP
REV.	DESCRIPTION	DATE	D	A

**PLANNING**



THE PARK  
LORD EDWARD ST.  
LIMERICK

30 DRUMCONDRA RD. UPPER  
DRUMCONDRA  
DUBLIN 9

TEL: 01-4278320 (Dublin)  
TEL: 061-416534 (Limerick)  
email: mail@dennanyreidy.ie  
website: www.dennanyreidy.ie

CLIENT: KERRY COUNTY COUNCIL, ARAS AN CHONTAE, RATHASS, TRALEE Co.KERRY,

PROJECT: HOUSING AT BALLOONAGH, TRALEE, Co.KERRY

TITLE: PROPOSED FOUL & SURFACE WATER LAYOUT

DATE:	27.03.2018	SCALES:	AS SHOWN
DRAWN BY:	STR	DRG. No.	K138-02
DESIGNED BY:	STR	REV.	B
CHECKED BY:	RP	REVISIONS:	B
APPROVED BY:	RP		

PROPOSED FOUL & SURFACE WATER LAYOUT  
SCALE: 1:250

