


Notes :

1. All drawings are to be read in conjunction with all relevant Specifications, Bills of Materials, Architectural, Services and Engineering drawings.
2. Any discrepancies between these documents shall be brought to the attention of the Engineer.
3. All dimensions are in millimetres, unless noted otherwise.
4. All levels are in metres related to Ordnance Datum.
5. Drawings are not to be scaled.

Legend:

- COM Existing Combined Drain
- FW New 150mm Dia uPVC Foul Drain (uno)
- FMH1 New Foul Manhole
- PSIC Private side inspection chambers as per Irish Water Specification. (600mm Dia Wavin Cosma 4D922)
- SW New 150mm Dia uPVC Storm Drain (uno)
- SMH1 New Storm Manhole
- W Existing 100mm Dia Watermain (uno)
- W New 100mm Dia Watermain
- SV / SC Sluice Valve or Scour Valve
- WM Water Meter
- +7.300 Existing Level

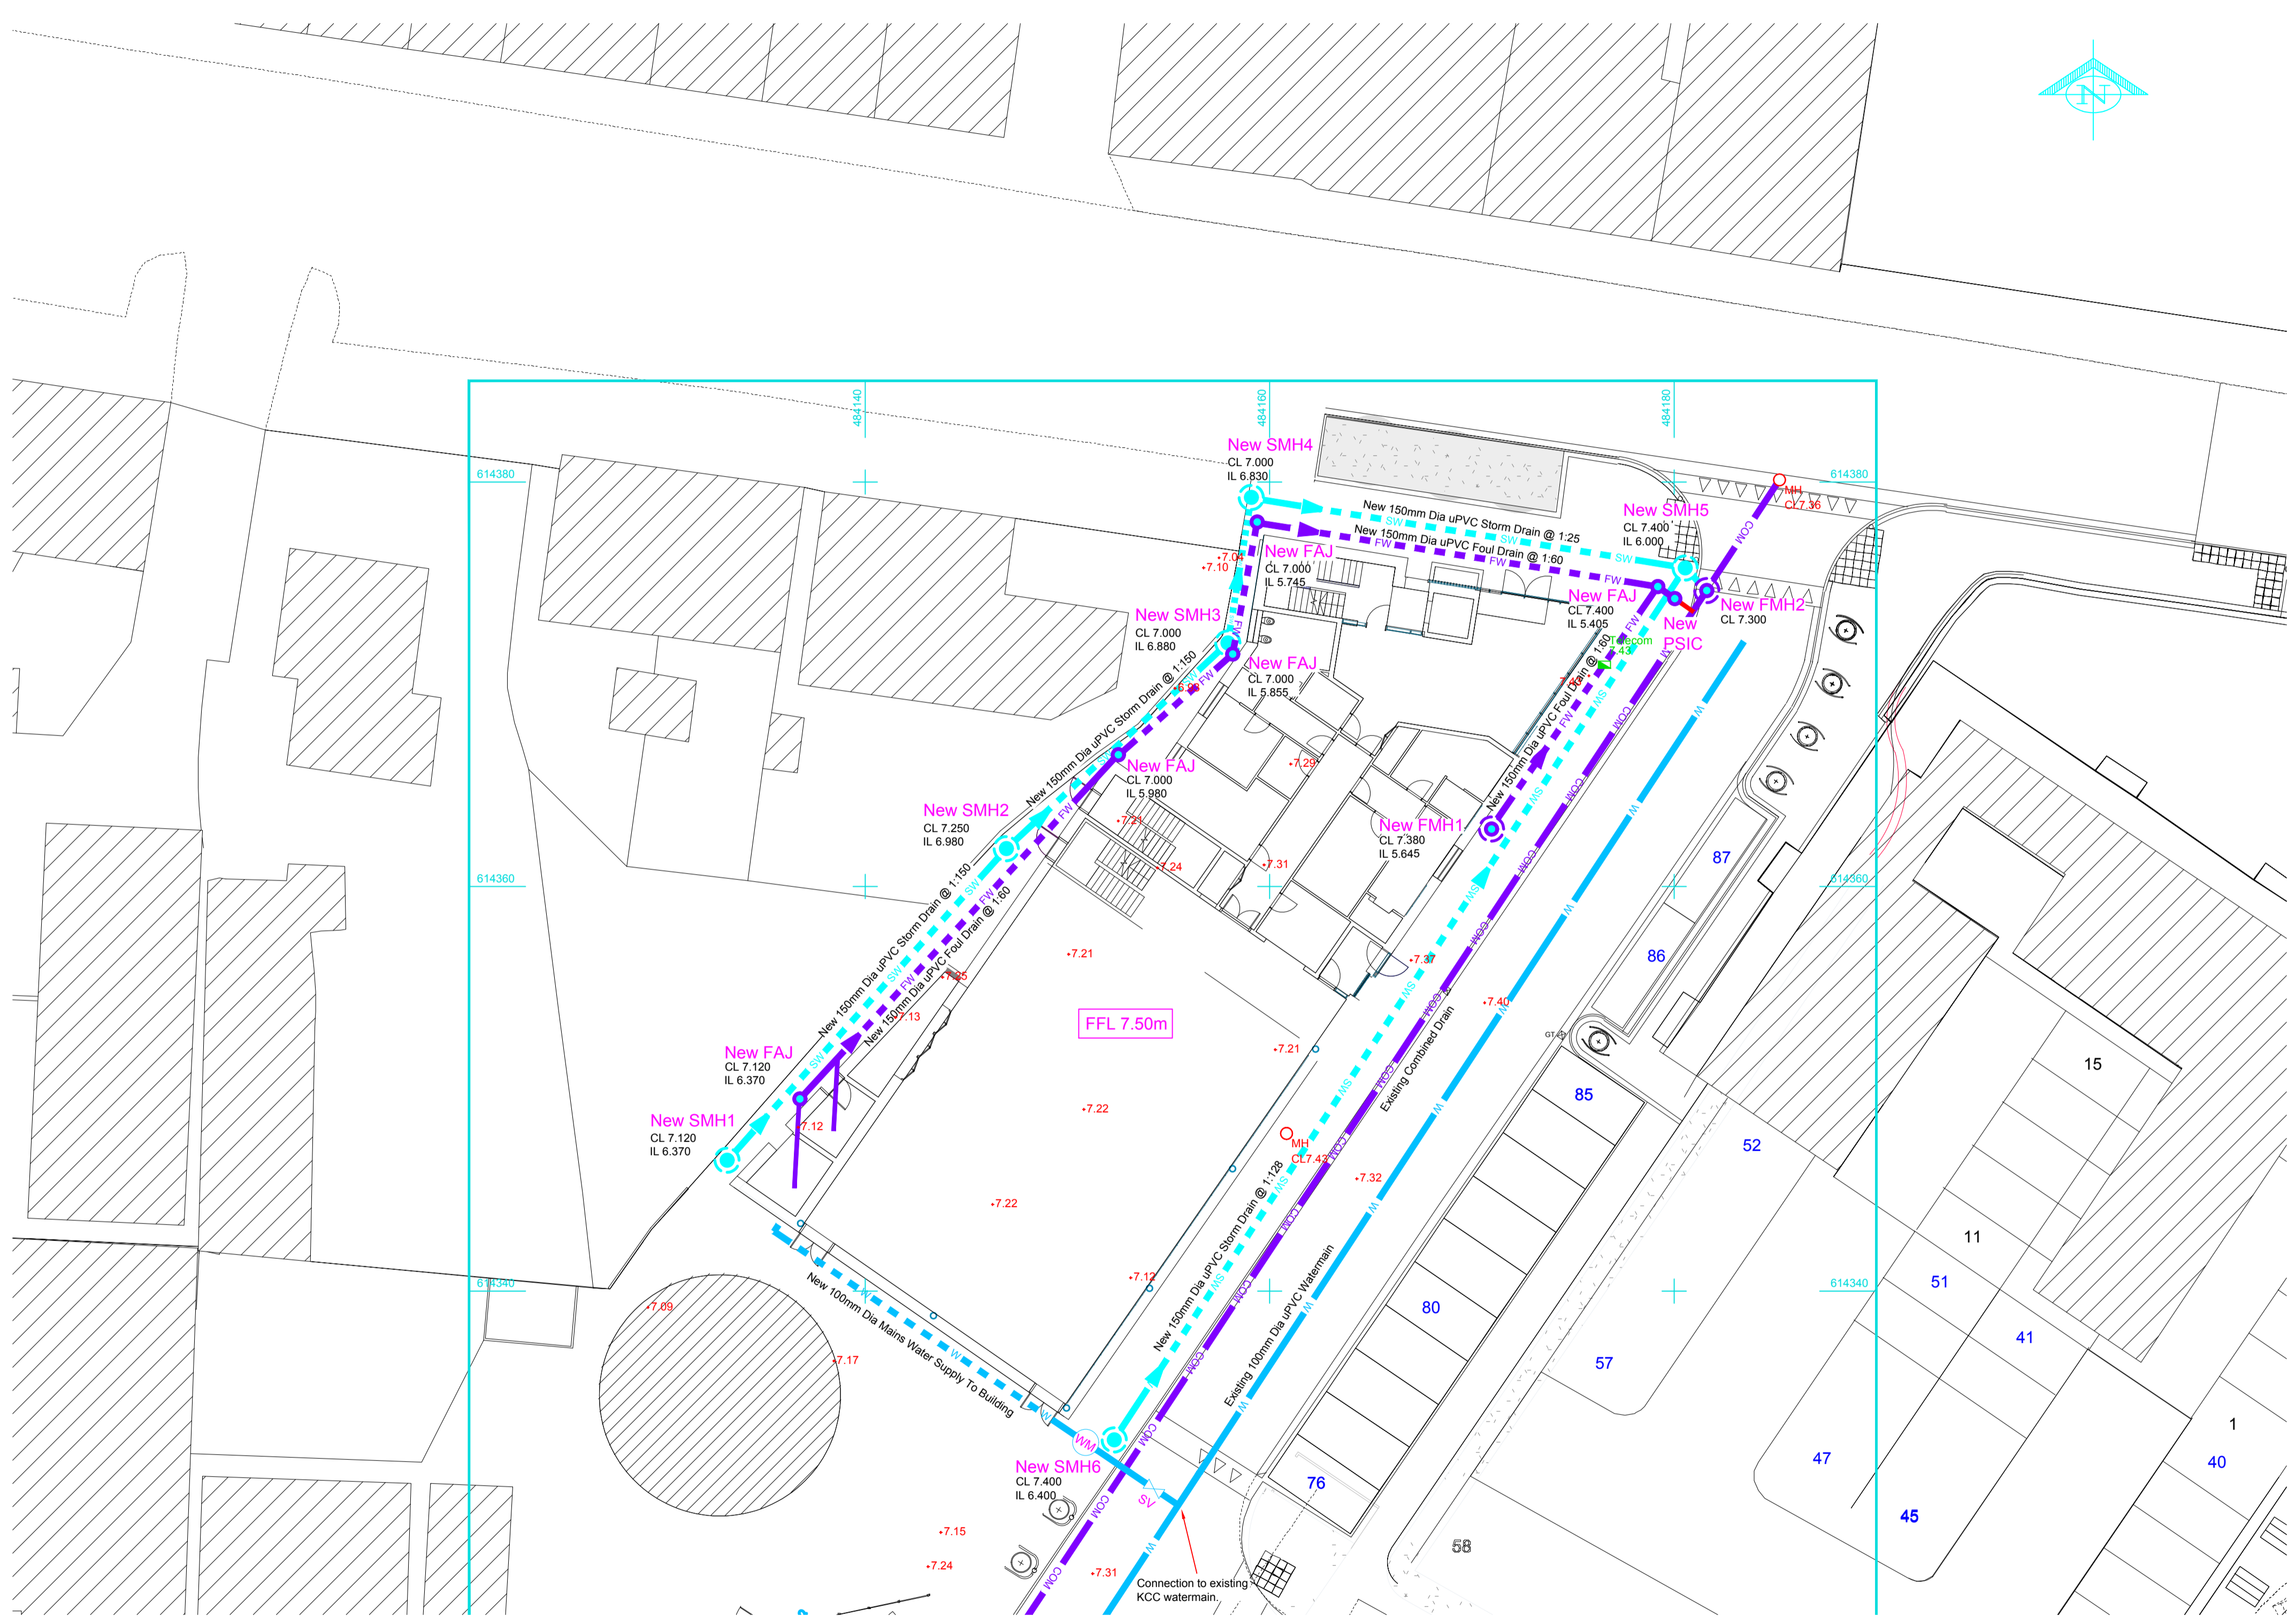

Proposed Drainage Layout Scale 1:200

Rev.	Date	Description	by	ch'd	app
B	14.05.2019	Watermain Revised. Re-issued For Part 8 Planning	ToC	IB	JOL
A	21.03.2019	Issued For Part 8 Planning	ToC	IB	JOL

Project
Tralee Boxing Club

Title
Proposed Drainage Layout

Client
Kerry County Council

Malachy Walsh and Partners
Consulting Engineers
Cork | Tralee | London | Limerick

Reen Point,
Blennerville,
Tralee,
Co. Kerry.

Tel : +353 (0)66 7123404
fax : +353 (0)66 7126586
E-mail : tralee@mwp.ie

Drawn	ToC	11.03.2019	18964-5001	B
Ch'd (Eng)	IB	11.03.2019		
Approved	JOL	11.03.2019		
Scales (A1) As Shown				